


SCHEMATIC NORTH ELEVATION

SCALE: 1/4" = 1'-0"

SCHEMATIC WEST ELEVATION

SCALE: 1/4" = 1'-0"

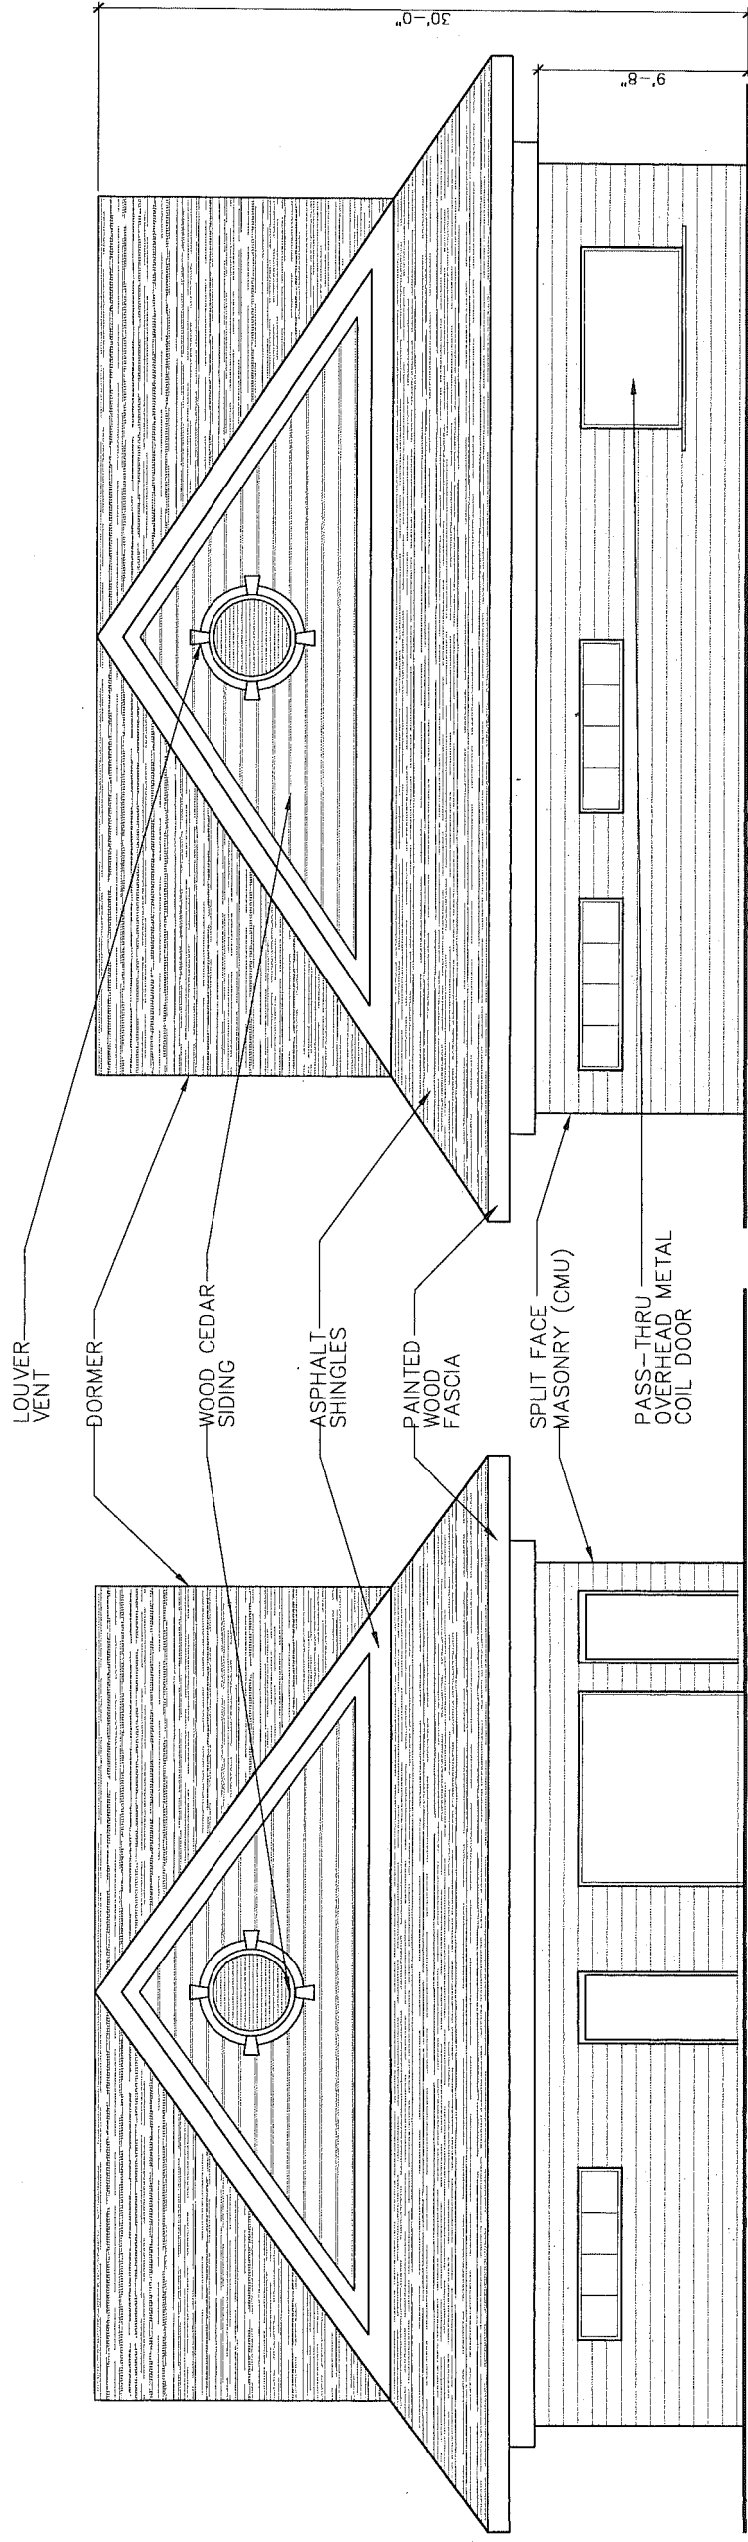

SCHEMATIC SOUTH ELEVATION

SCALE: 1/4" = 1'-0"

SCHEMATIC EAST ELEVATION

SCALE: 1/4" = 1'-0"

WARWICK FIRE FIGHTERS
SOCCER CLUB
WARWICK, RI
NEW CONCESSION &
RESTROOM PAVILLION

STAMP:

PROJECT STATUS:
**PRELIMINARY
NOT FOR
CONSTRUCTION**

DATE: 12/16/2015

PROJECT NO: 10001

DRAWN BY: JC

CHECKED BY: JC

© 2015
THESE DOCUMENTS HAVE BEEN
PREPARED BY THE ARCHITECT
PROJECT LISTED ABOVE. THEY ARE NOT
SUITABLE FOR USE ON OTHER PROJECTS
WITHOUT THE WRITTEN CONSENT AND
APPROVAL AND PARTICIPATION OF
JOSEPH CALDEIRA. REPRODUCTION IS
PROHIBITED.

REVISIONS:

DRAWING TITLE:

BUILDING
ELEVATIONS

DRAWING NO.:

A2.1

LEGEND

	NEW CONCRETE MASONRY WALL (CMU)
	8" AT EXTERIOR WALL / 6" AT INTERIOR WALLS
	NEW 3'-0" X 7'-0" INSULATED METAL DOOR
	NEW WALL HUNG WHITE VITREOUS CHINA WATER CLOSET
	NEW WALL HUNG WHITE VITREOUS CHINA URINAL
	NEW WALL HUNG WHITE VITREOUS CHINA HAND SINK

CODE SUMMARY

APPLICABLE CODES
 RI STATE BUILDING CODE (WITH AMENDMENTS)
 SBC-01-2013
 RI FIRE SAFETY CODE 2014-2015
 NFPA LIFE SAFETY CODE 101 2012 EDITION

BUILDING AREA: 1,760 S.F.
 STORIES: ONE (SLAB ON GRADE)
 USER GROUP: A5 ASSEMBLY OCCUPANCY
 CONSTRUCTION CLASSIFICATION: 5B UNPROTECTED

OCCUPANCY LOAD:
 FOOD CONCESSION 100S.F./PERSON (330S.F.) 4 PERSONS
 RESTROOMS 50S.F./PERSON (400S.F.) 8 PERSONS
 MULT-USE SPACE 100S.F./PERSON (517S.F.) 5 PERSONS
 STORAGE 100S.F./PERSON (310S.F.) 1 PERSON
 TOTAL 18


PLUMBING FIXTURE ANALYSIS
 EXTERIOR FACILITY (SPECTATORS) 156 PERSONS
 EXTERIOR FACILITY (PLAYERS & OFFICIALS) 84 PERSONS
 TOTAL 240 PERSONS

BUILDING OCCUPANCY: 18 PERSONS
TOTAL OCCUPANCY: 258 PERSONS

50% FEMALE: 129 PERSONS
 50% MALE: 129 PERSONS

FEMALE: 1 WATER CLOSET/40 PERSONS (3 PROVIDED)
 1 LAVATORY /150 PERSONS (2 PROVIDED)

MALE: 1 WATER CLOSET /75 PERSONS (2 WC & 2 URINALS PROVIDED)
 1 LAVATORY /150 PERSONS (2 PROVIDED)

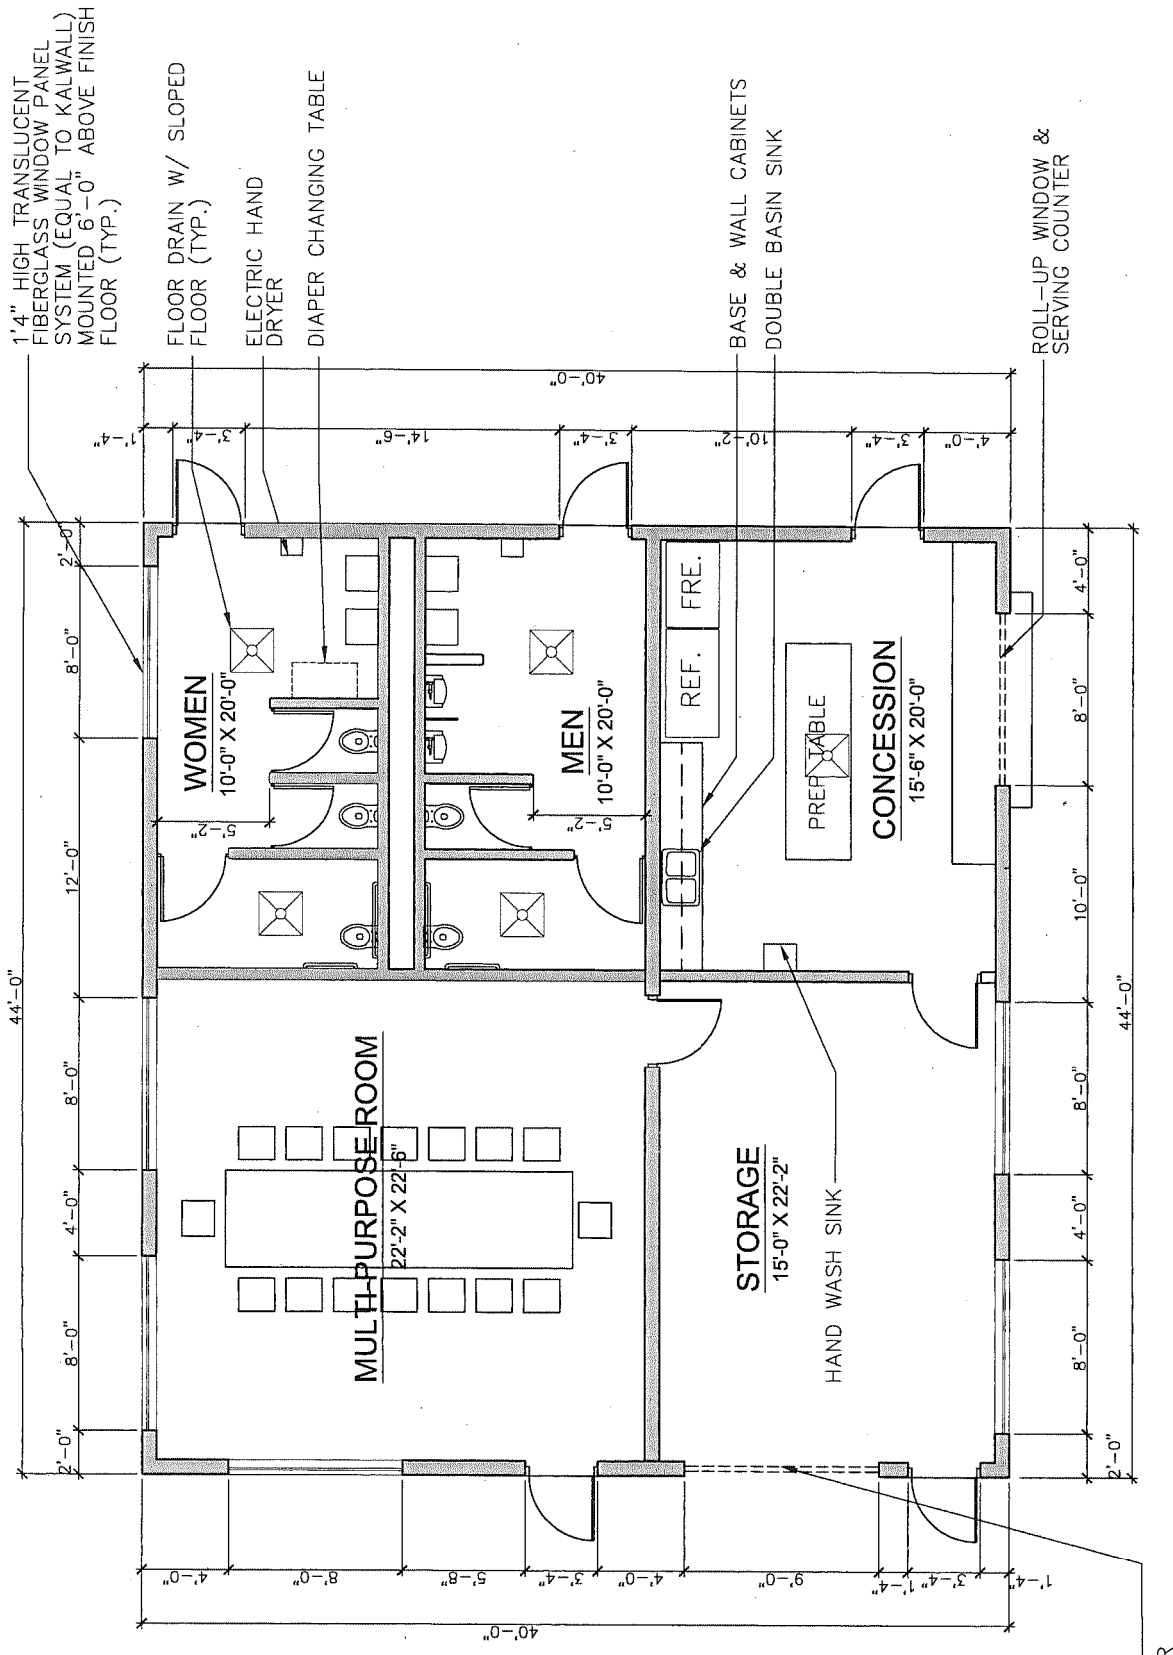

SCHEMATIC FLOOR PLAN

SCALE: 1/4" = 1'-0" AREA = 1,760 S.F.

FLOOR PLAN

DRAWING NO.

A1.1

WARWICK FIRE FIGHTERS
 SOCCER CLUB
 WARWICK, RI
 NEW CONCESSION &
 RESTROOM PAVILLION

PROJECT STATUS:
**PRELIMINARY
 NOT FOR
 CONSTRUCTION**

DATE: 12-16-2015

PROJECT NO: 15001

DRAWN BY: JC

CHECKED BY: JC

© 2015

THESE DOCUMENTS HAVE BEEN
 PREPARED BY THE ARCHITECT
 PROJECT LISTED ABOVE. THEY ARE NOT
 TO BE USED FOR ANY OTHER PROJECTS
 WITHOUT THE WRITTEN CONSENT OF THE
 ARCHITECT. APPROVAL AND PARTICIPATION OF
 THE ARCHITECT IS REQUIRED FOR ANY
 REVISIONS, REPRODUCTION OR
 DISTRIBUTION.

REVISIONS:

DRAWING TITLE: